



- NOTES:**
- FOR GENERAL NOTES, SYMBOLS, AND ABBREVIATIONS SEE DRAWING PL000.
 - FOR FIXTURE CONNECTION SIZES, REFER TO PLUMBING FIXTURE SCHEDULE ON PL600.
 - ALL ITEMS THAT REQUIRE ACCESS, SUCH AS FOR OPERATING, CLEANING, SERVICING, MAINTENANCE, AND CALIBRATION, SHALL BE EASILY AND SAFELY ACCESSIBLE BY PERSONS STANDING AT FLOOR LEVEL, OR STANDING ON PERMANENT PLATFORMS, WITHOUT THE USE OF PORTABLE LADDERS. EXAMPLES OF THESE ITEMS INCLUDE, BUT ARE NOT LIMITED TO: ALL TYPES OF VALVES, FILTERS AND STRAINERS, TRANSMITTERS, CONTROL DEVICES. PRIOR TO COMMENCING INSTALLATION WORK, REFER CONFLICTS TO THE COR FOR RESOLUTION. FAILURE OF THE CONTRACTOR TO RESOLVE, OR POINT OUT ANY ISSUES WILL RESULT IN THE CONTRACTOR CORRECTING AT NO ADDITIONAL COST OR TIME TO THE GOVERNMENT.

- KEYED NOTES: (#)**
- WATER QUALITY MONITORING SYSTEM. REFER TO SPECIFICATION 22 05 19 METERS AND GAUGES FOR PLUMBING AND PIPING.
 - ALLOW 20" OF LAY LENGTH FOR 1" CITY WATER METER INSTALLATION. REFER TO DETAIL 3/PL501. LINES MAY BE STACKED PER DETAIL.

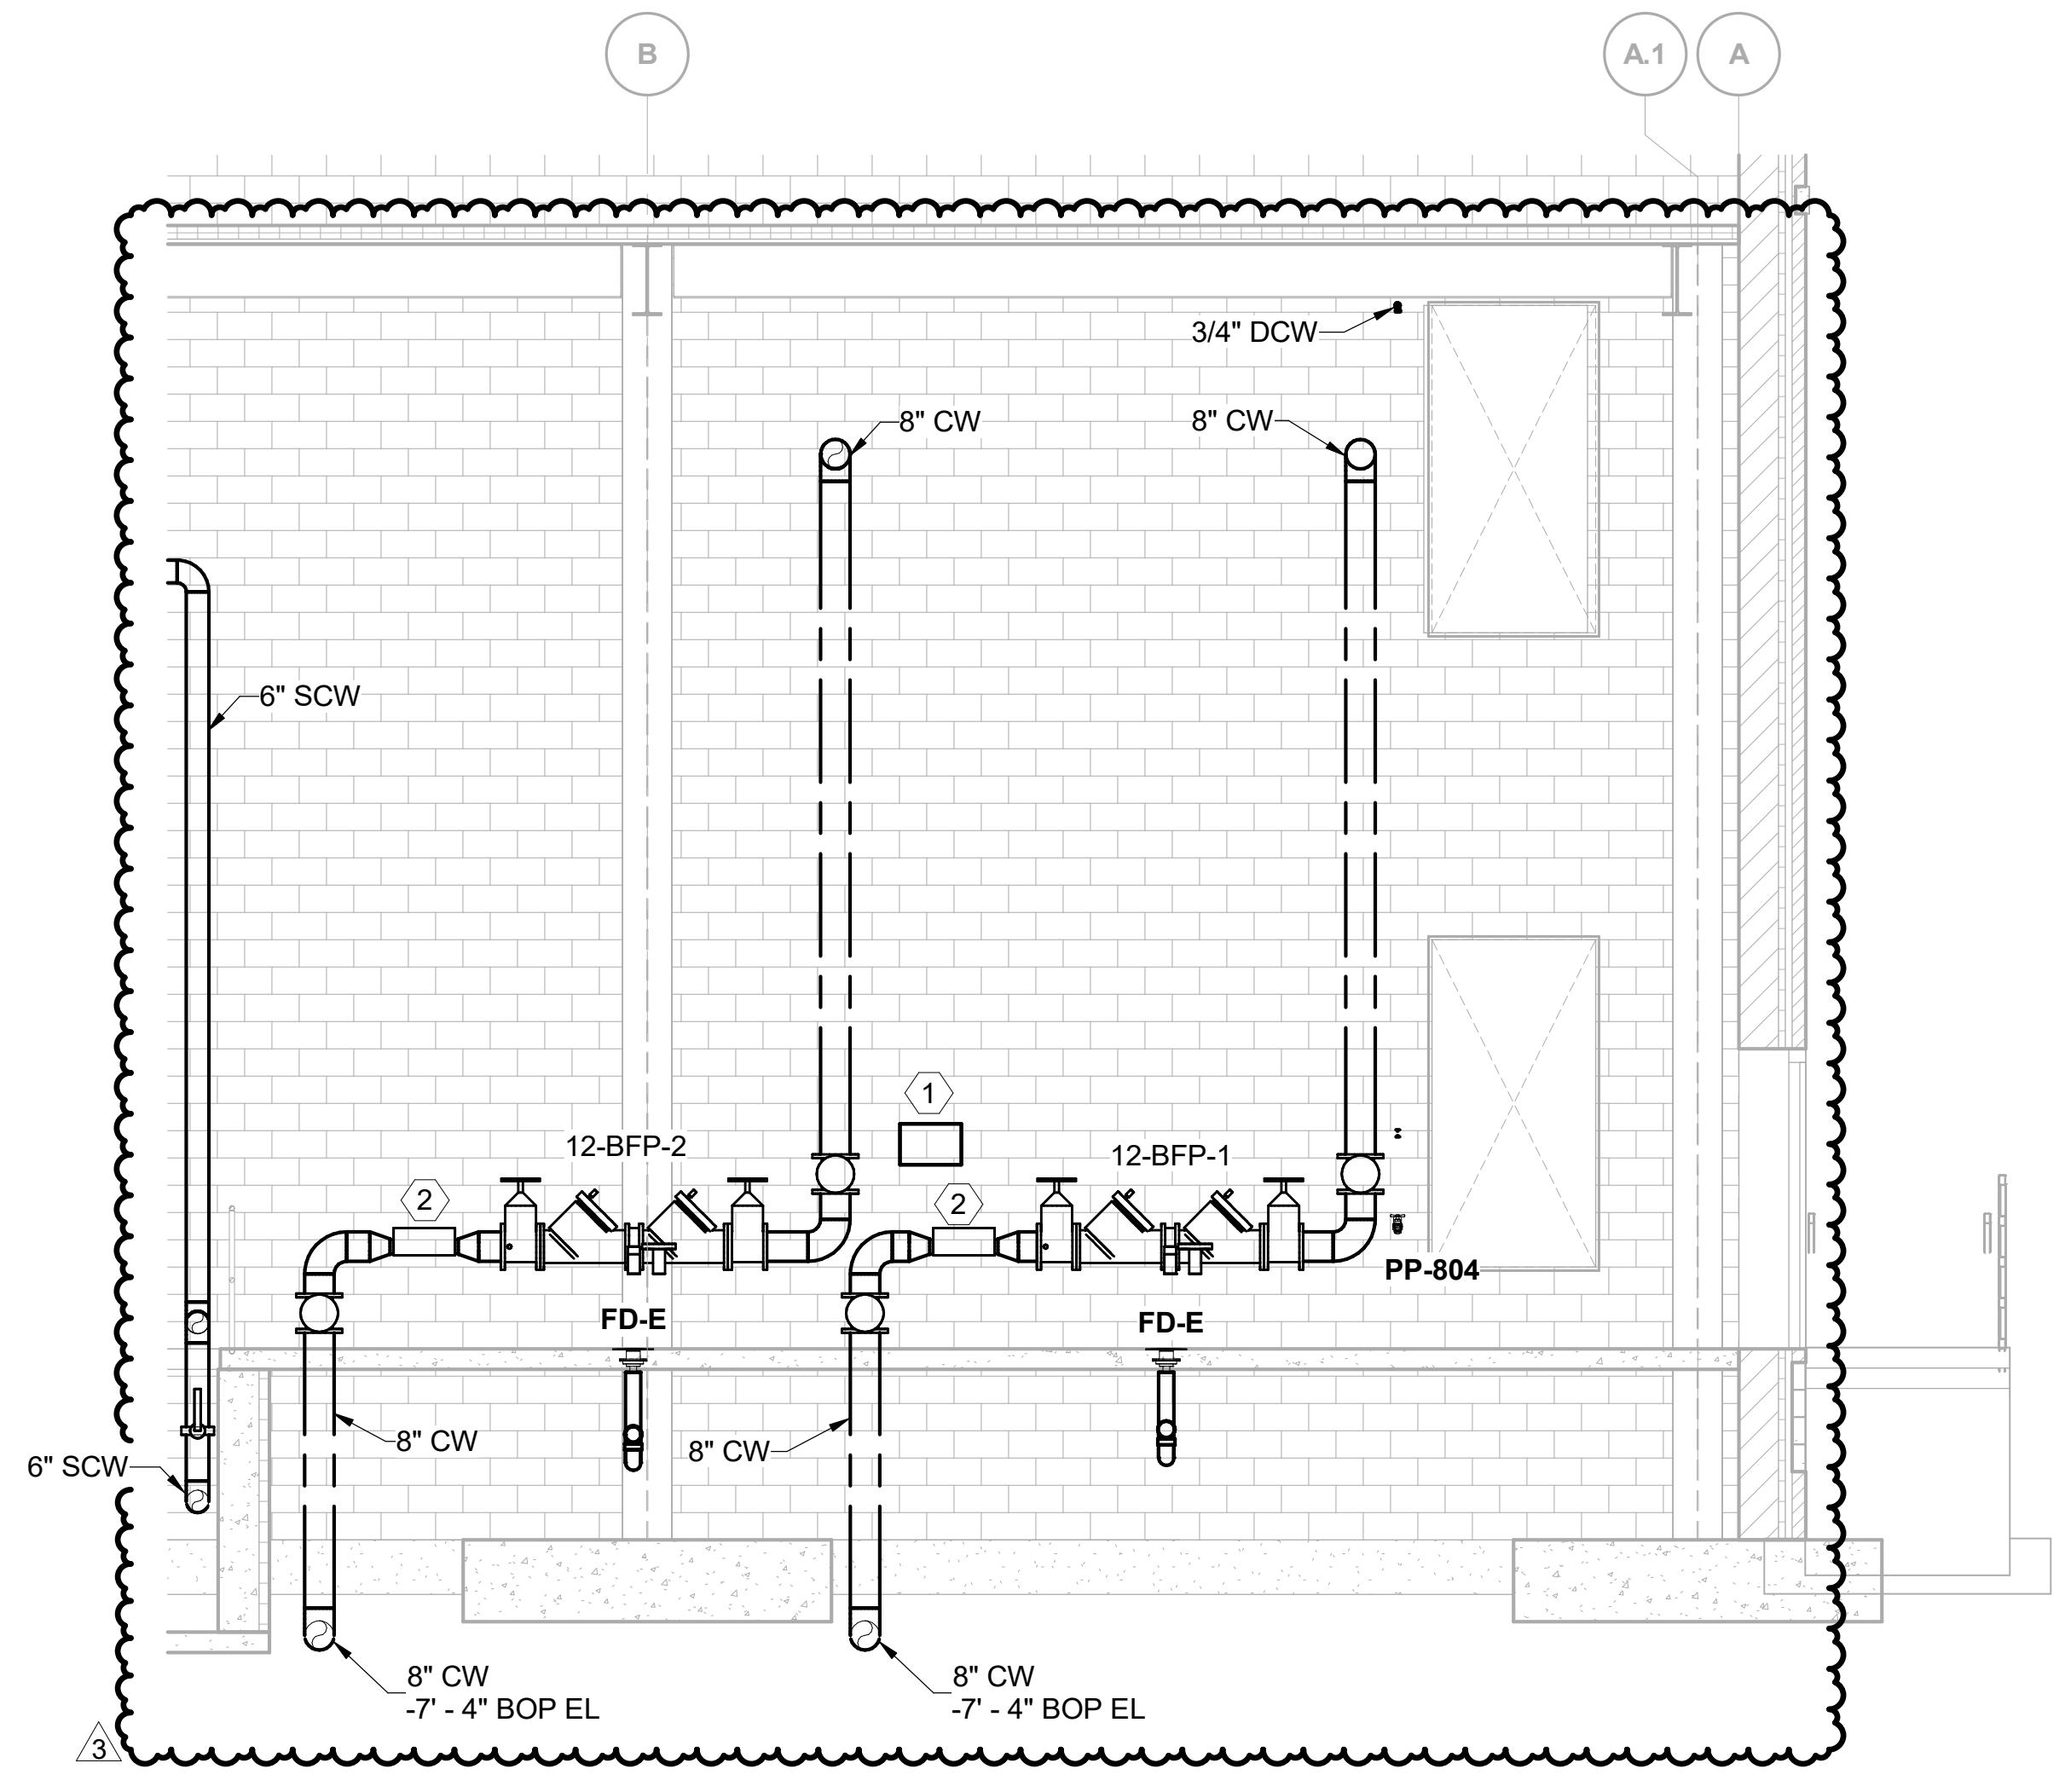

SECTION 1
BFP SECTION
PL101
SCALE IN FEET
0 2' 4' 8'

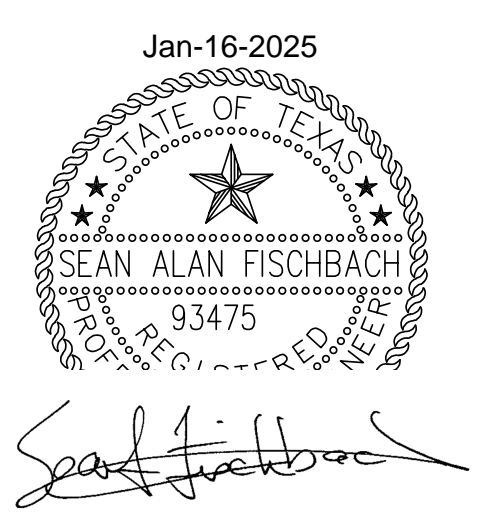

Revisions: /3 Addendum 3 Date:	CONSULTANT BURNS & McDONNELL <small>Burns & McDonnell Engineering Company, Inc. 9450 WARD PARKWAY, KANSAS CITY, MO</small>	ARCHITECT/ENGINEER OF RECORD paradigm <small>Architecture Engineering Design-Build 200 Envoy Circle, Suite 201, Louisville, KY 40299 www.paradigmusa.com</small>	STAMP	Office of Construction and Facilities Management VA U.S. Department of Veterans Affairs	Drawing Title PLUMBING SECTIONS	Phase 100% CONSTRUCTION DOCUMENTS	Project Title SIOUX FALLS BOILER PLANT	Project Number 438-22-900
					Approved: Project Director	FULLY SPRINKLERED	Location VAMC-Sioux Falls: 2501 W 22nd St, Sioux Falls, SD 57105	Building Number 12